
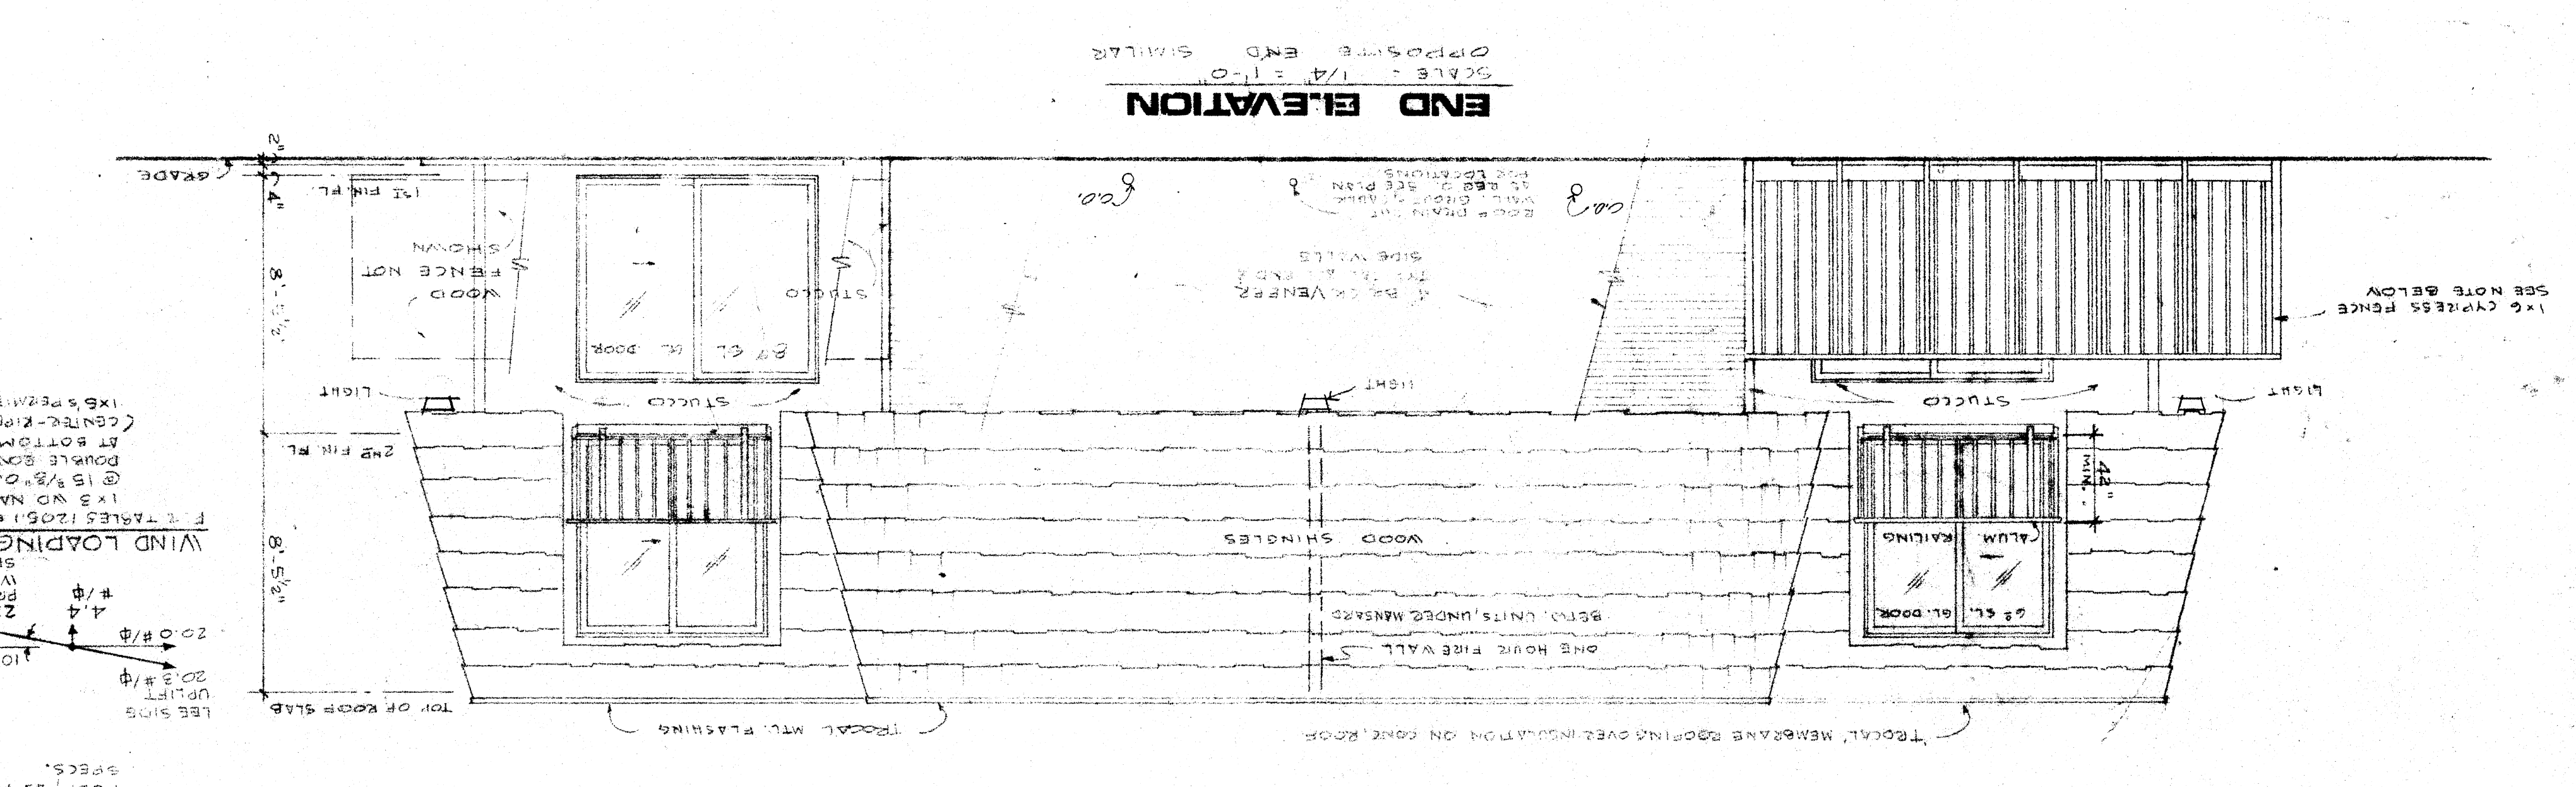
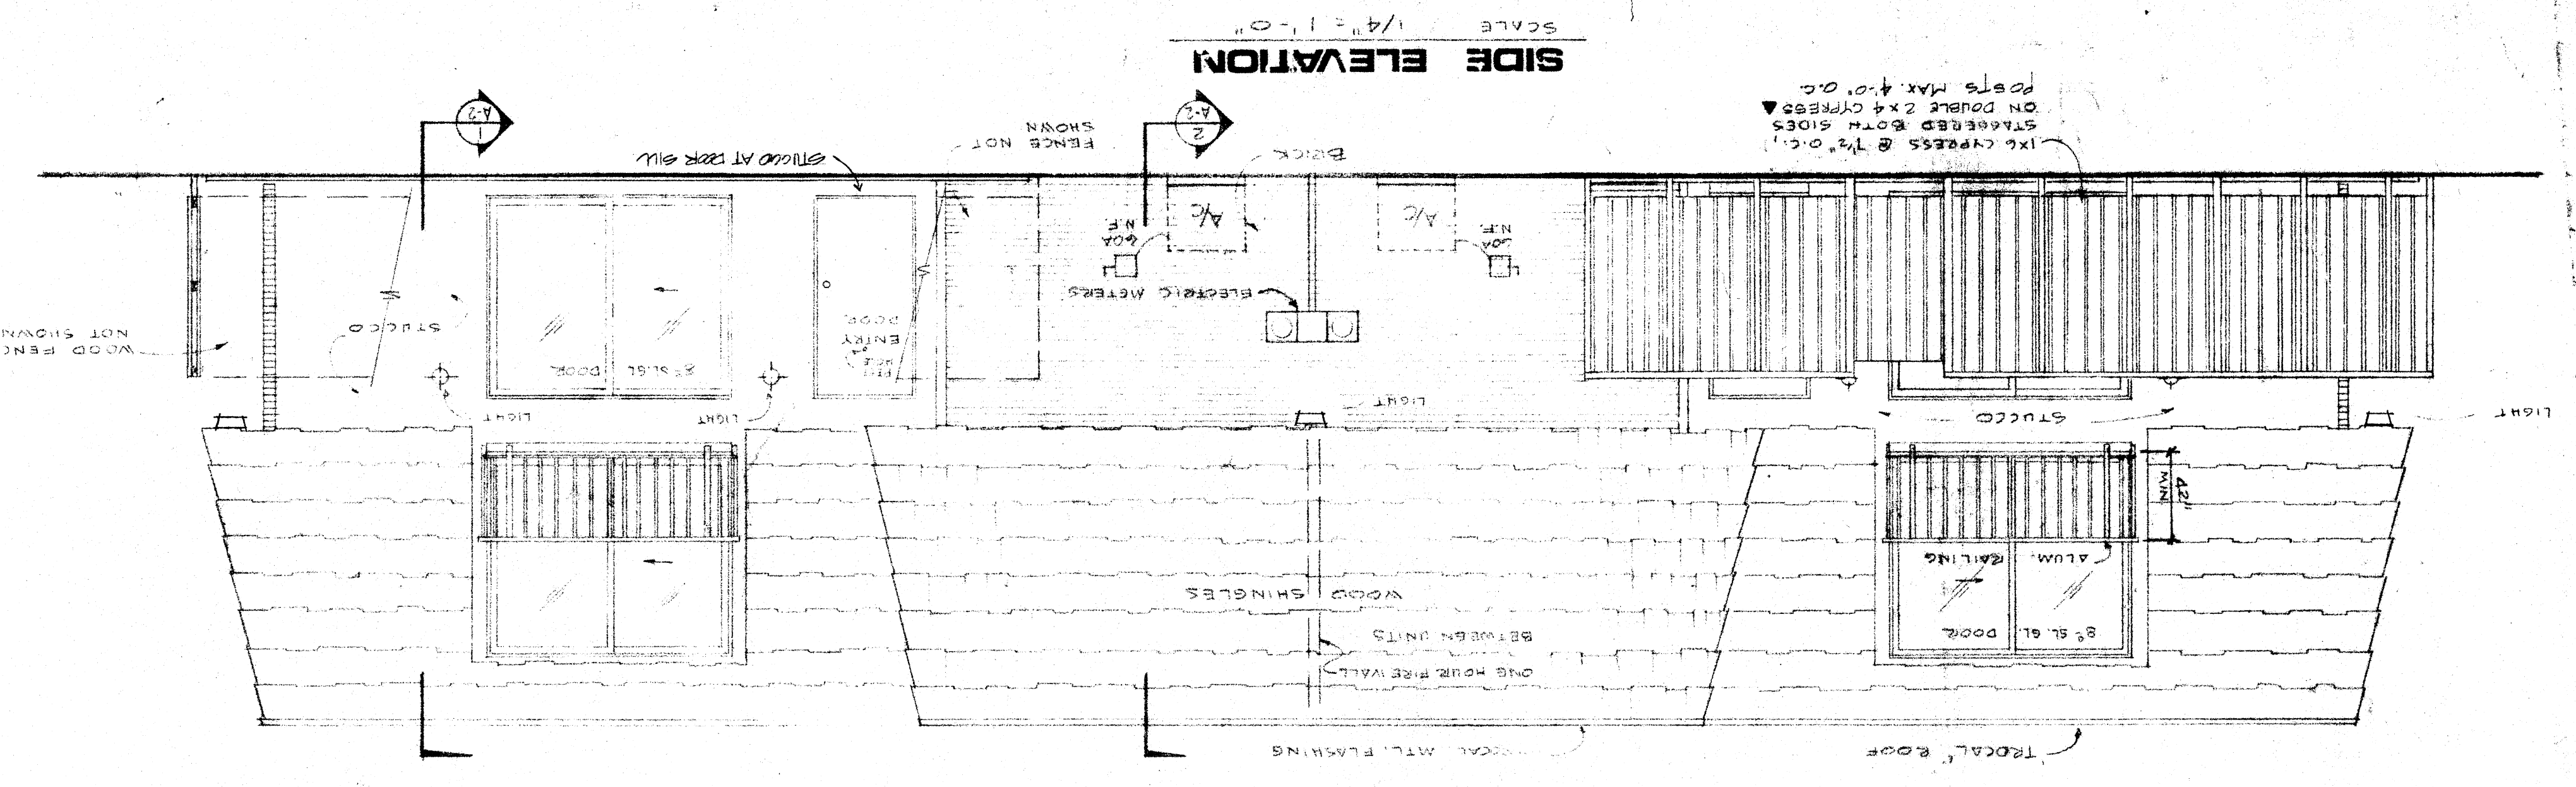


PROJECT NO. DATE DRAWN BY: JTN, JML, JML CHECKED BY: JTN, JML, JML REVISED: JTN, JML, JML

HERITAGE VILLAGE

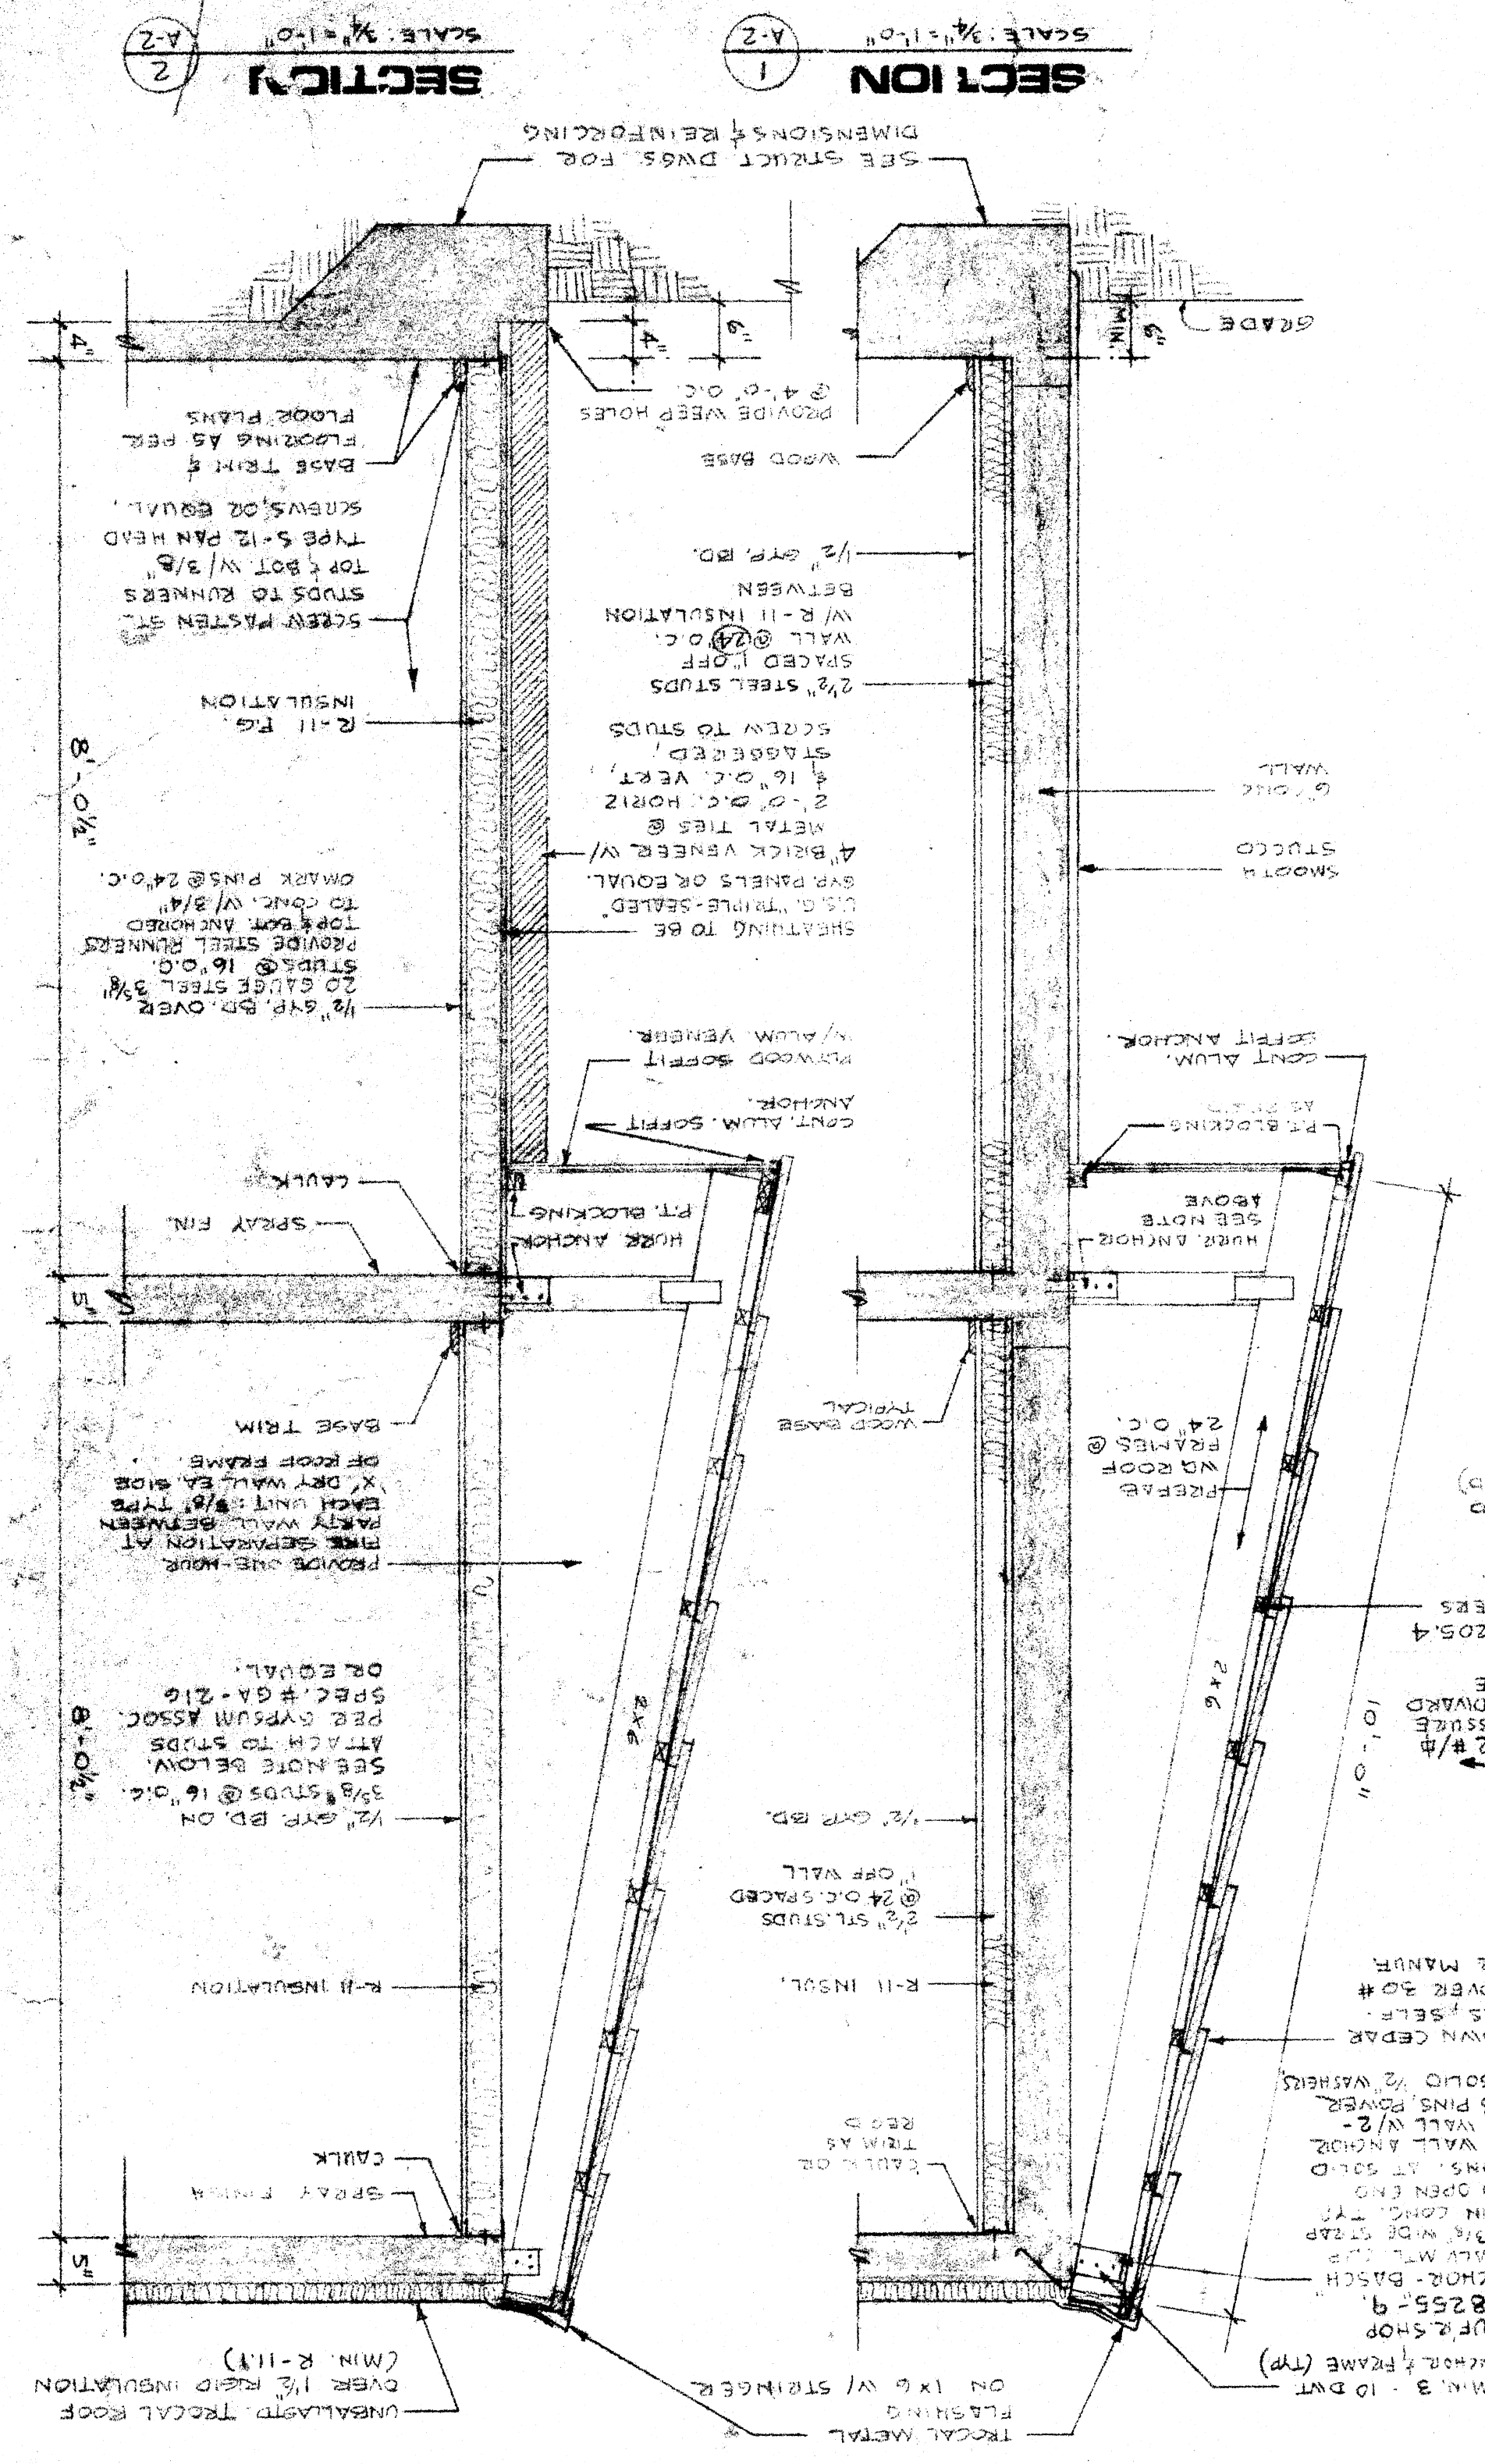

ELECTRIC PANEL & RISER DIAGRAM


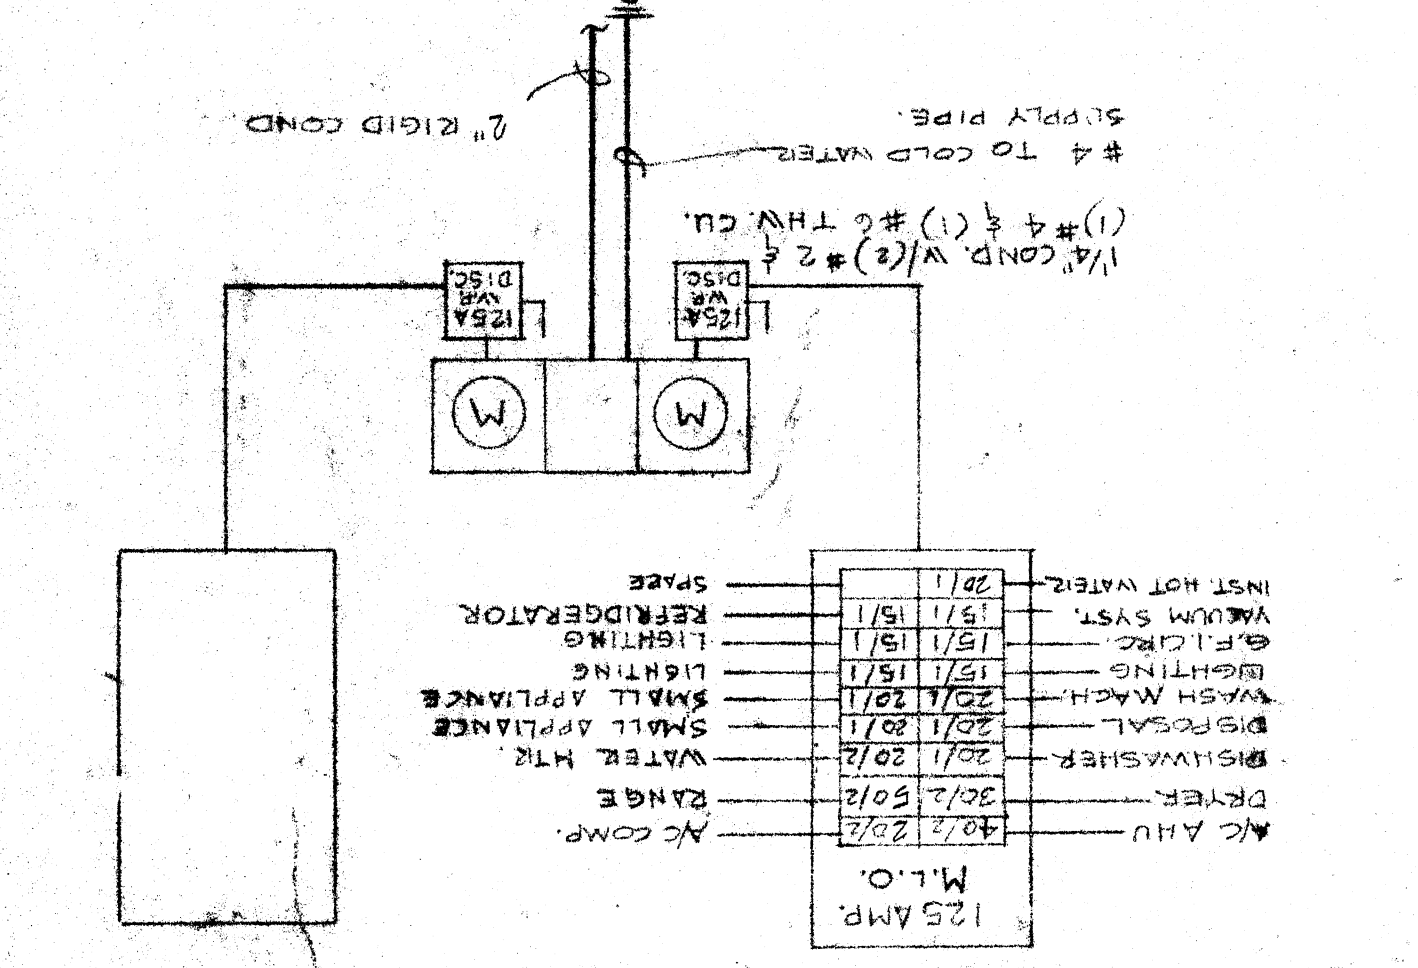



Table with columns for 'TYPICAL UNIT DEMAND', '1192 # 3 WATTS/#', and '2 SMALL APPLIANCE CIRCUITS'. It lists various building components and their corresponding electrical demands.

ANCHORING AND WIND LOADING: EXPOSED STEEL STUD END WALLS ARE SUBJECT TO HORIZONTAL WIND LOADS ONLY. PER TABLE 1208 OF 2001 IBC BUILDING CODE...

END ELEVATION

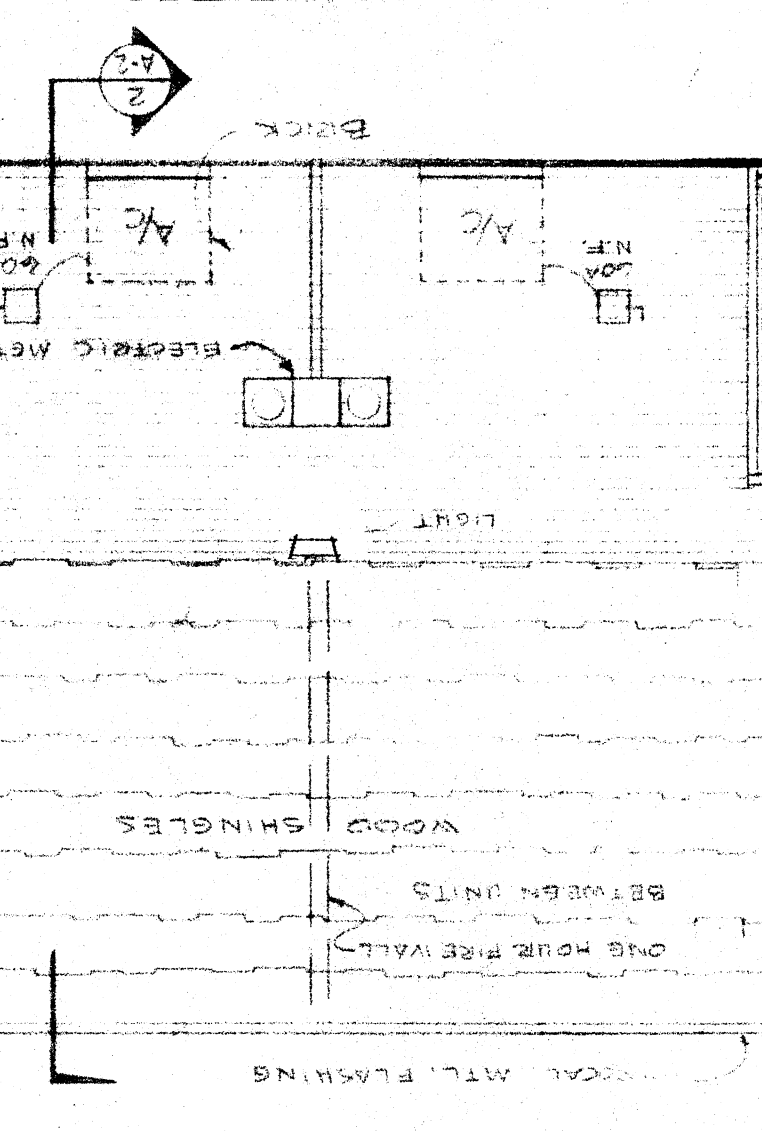

SIDE ELEVATION

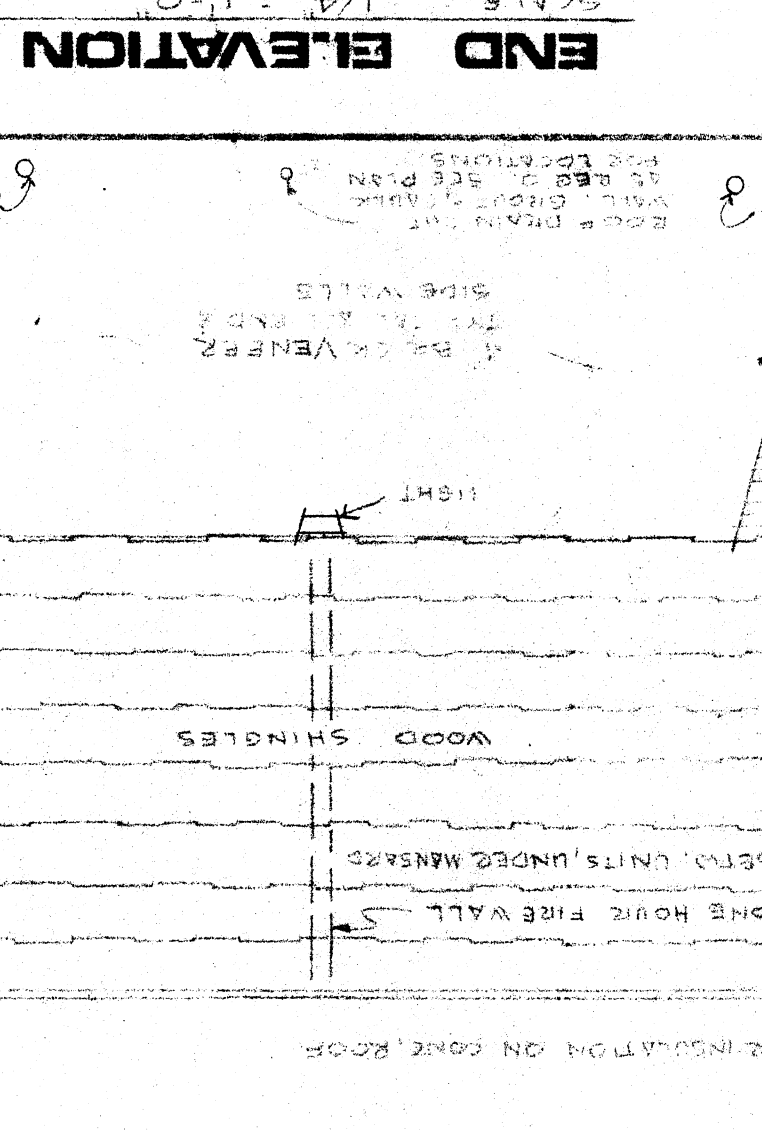

PLUMBING RISER DIAGRAM

